


NB; THIS IS A GENERIC DIAGRAM. THE BIDDERS ARE EXPECTED TO SUBMIT A DETAILED SINGLE LINE DIAGRAM WITH ALL SAFETY AND OPERATIONAL FEATURES AS DESCRIBED IN THE TENDER DOCUMENTS.

KENYA POWER & LIGHTING CO. LTD	KP1/12A-2/PT/3/14/A35 - DESIGN, SUPPLY, INSTALLATION AND COMMISSIONING OF 33KV GAS INSULATED SWITCHGEAR (GIS) AT KIPEVU.
11KV SINGLE LINE DIAGRAM	

SIZE	FSCM NO	DWG NO	REV
SCALE	1:1	SHEET	1 OF 2

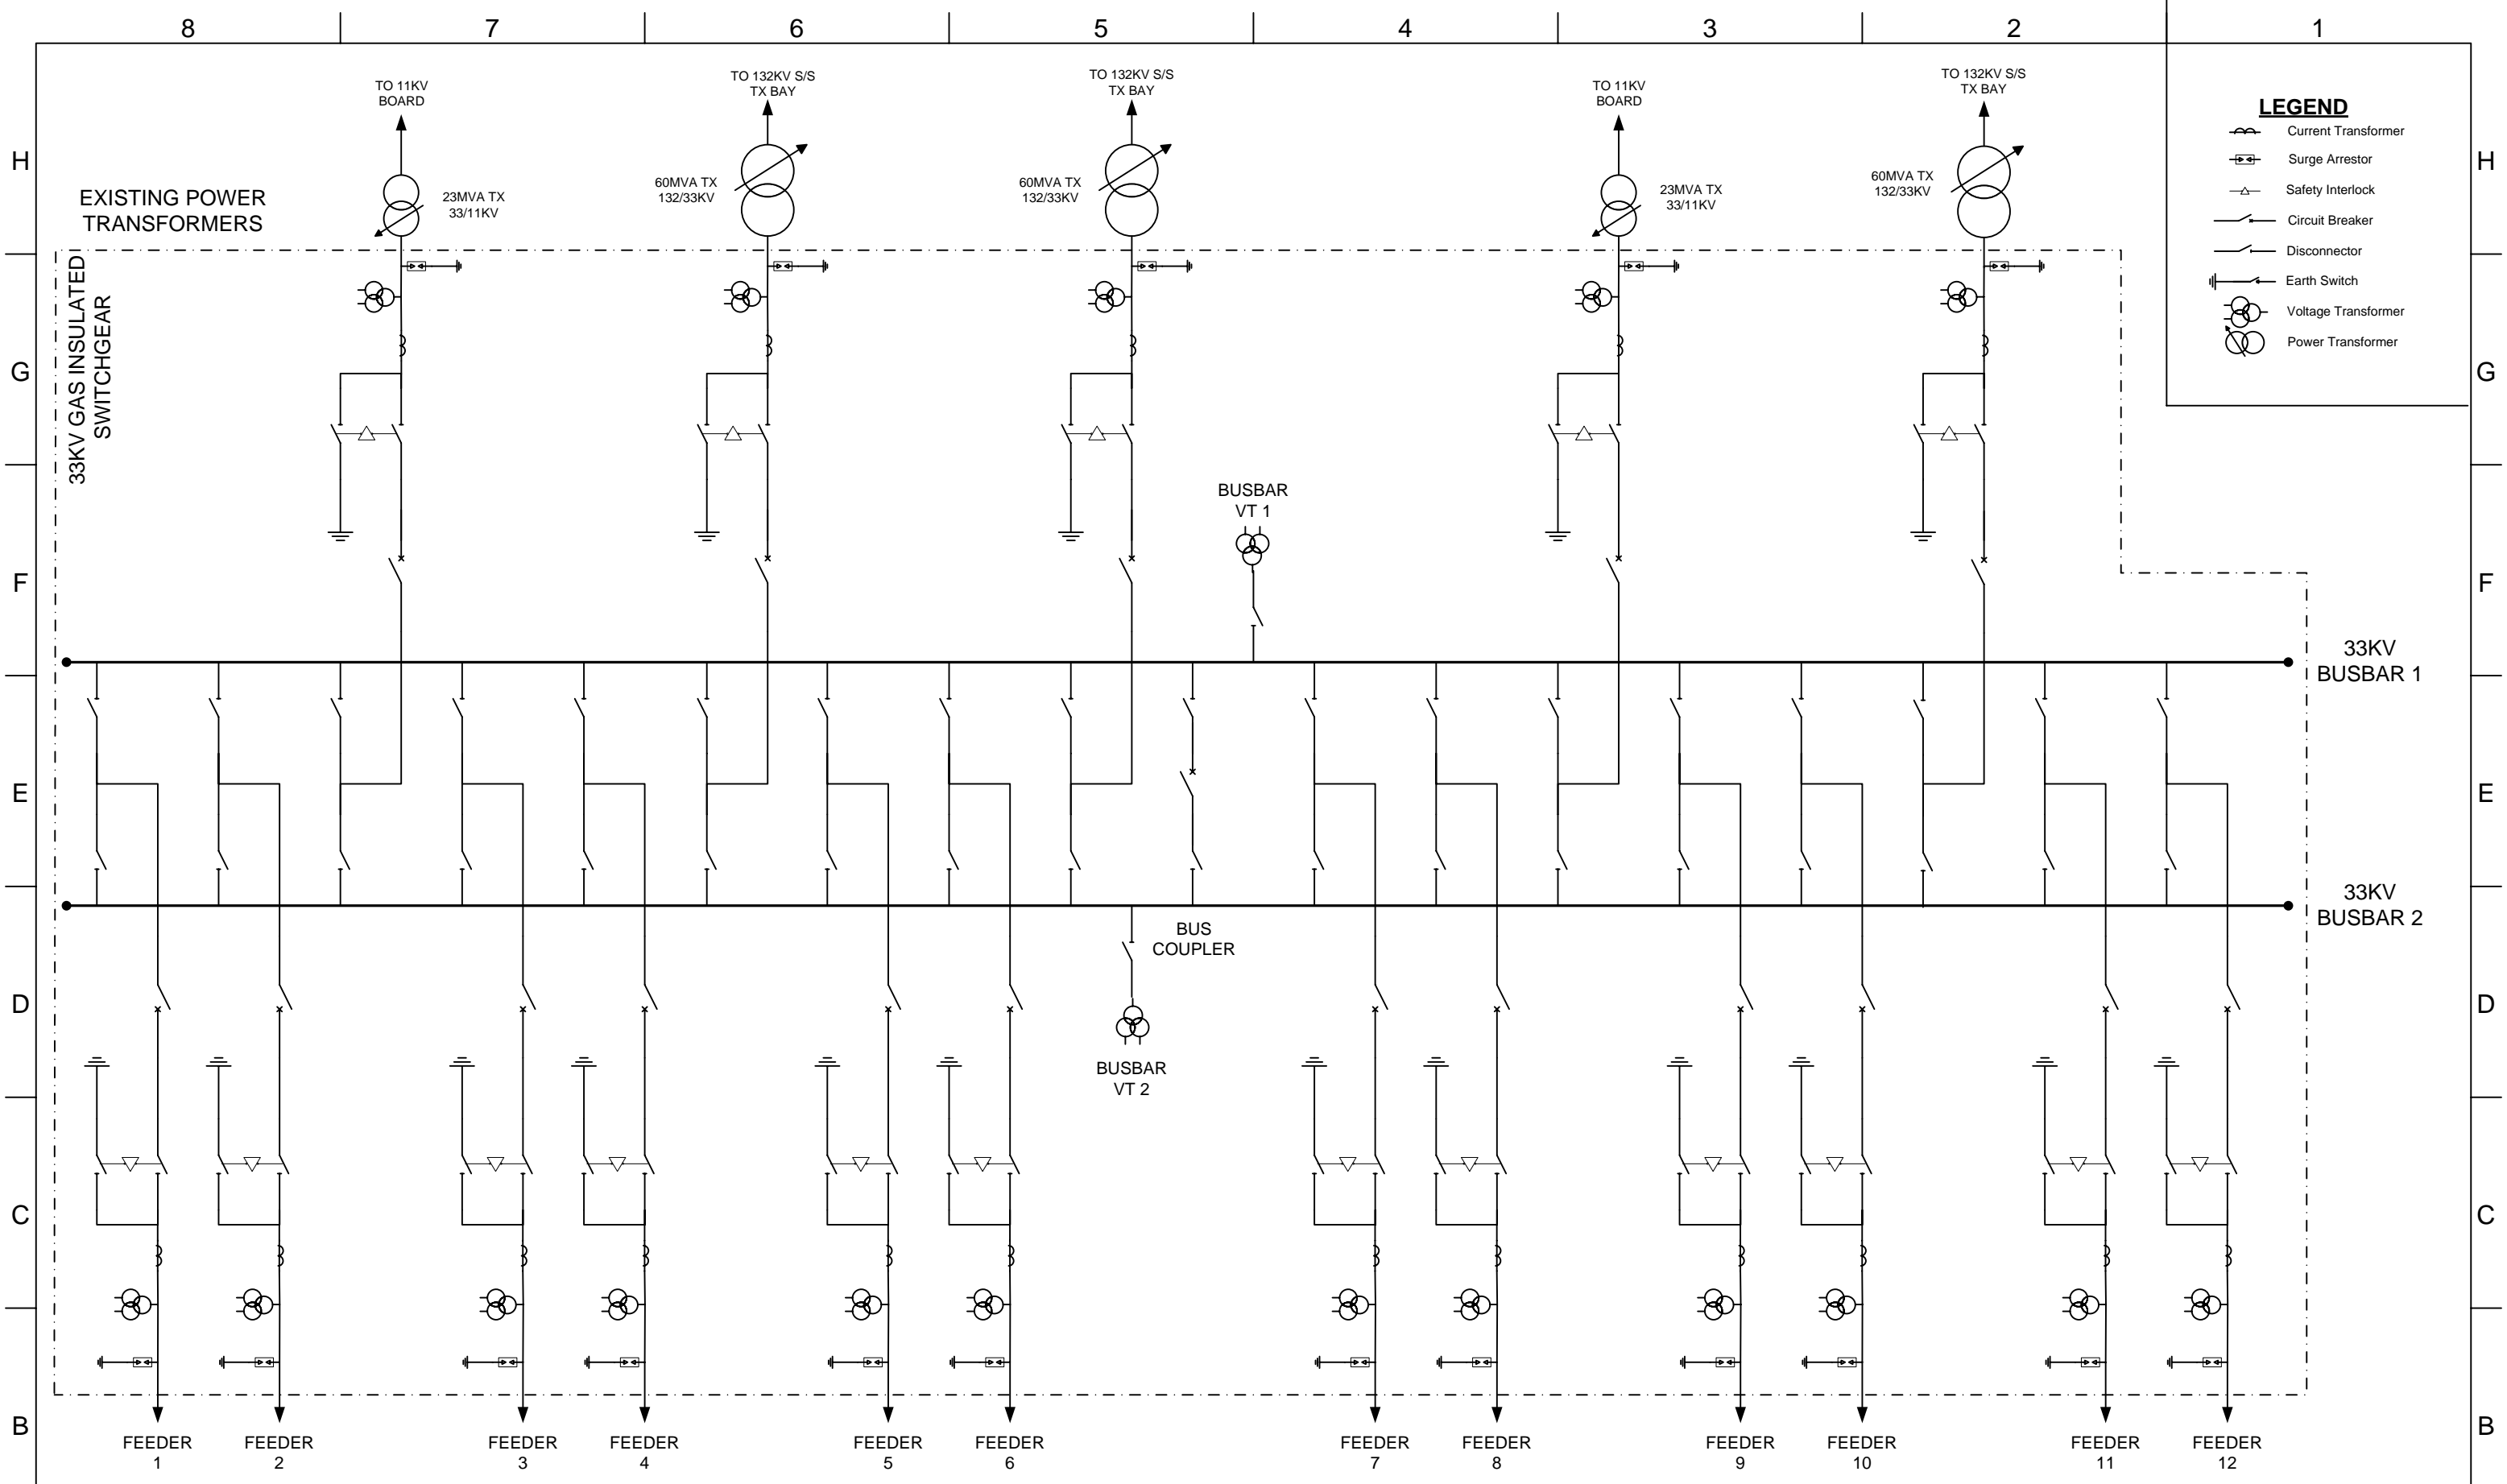

NB; THIS IS A GENERIC DIAGRAM. THE BIDDERS ARE EXPECTED TO SUBMIT A DETAILED SINGLE LINE DIAGRAM WITH ALL SAFETY AND OPERATIONAL FEATURES AS DESCRIBED IN THE TENDER DOCUMENTS.

KENYA POWER & LIGHTING CO. LTD

KP1/12A-2/PT/3/14/A35 - DESIGN, SUPPLY, INSTALLATION AND COMMISSIONING OF 33KV GAS INSULATED SWITCHGEAR (GIS) AT KIPEVU.

33KV SINGLE LINE DIAGRAM

SIZE	FSCM NO	DWG NO	REV
SCALE	1 : 1	SHEET	2 OF 2