



APPENDIX 1

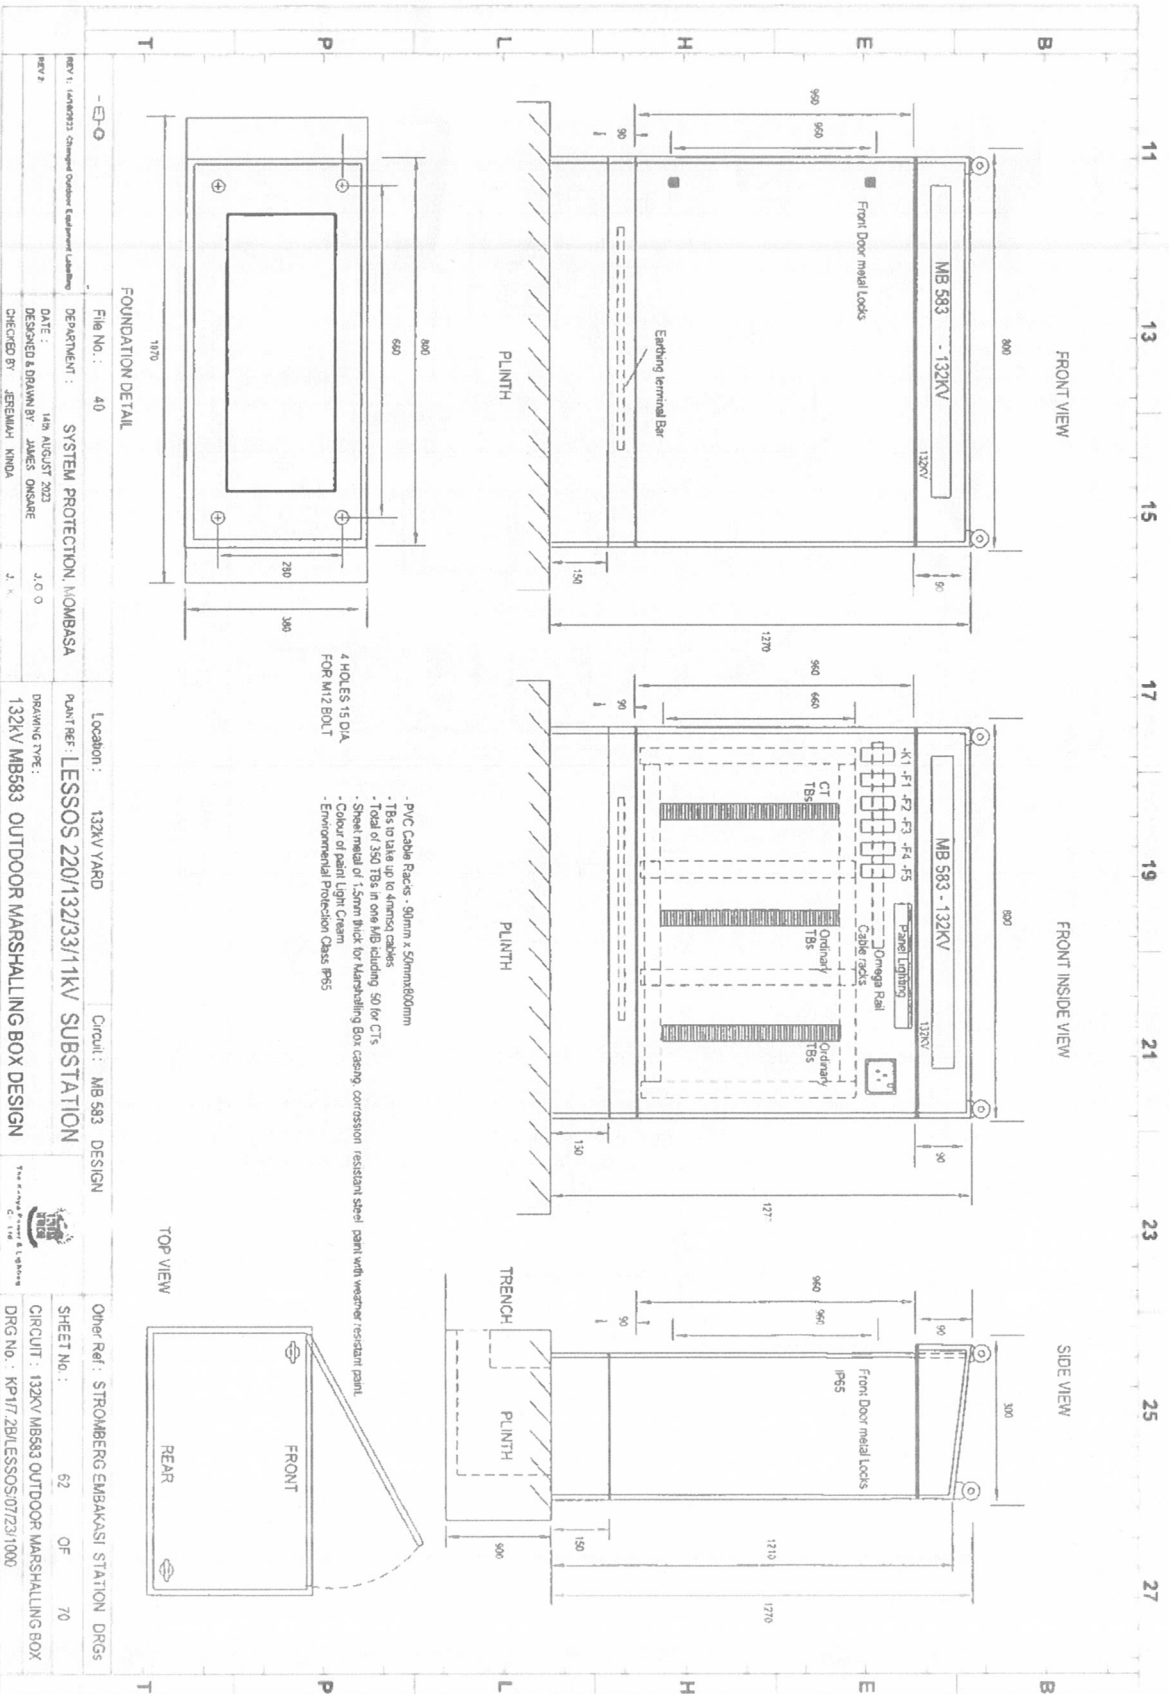

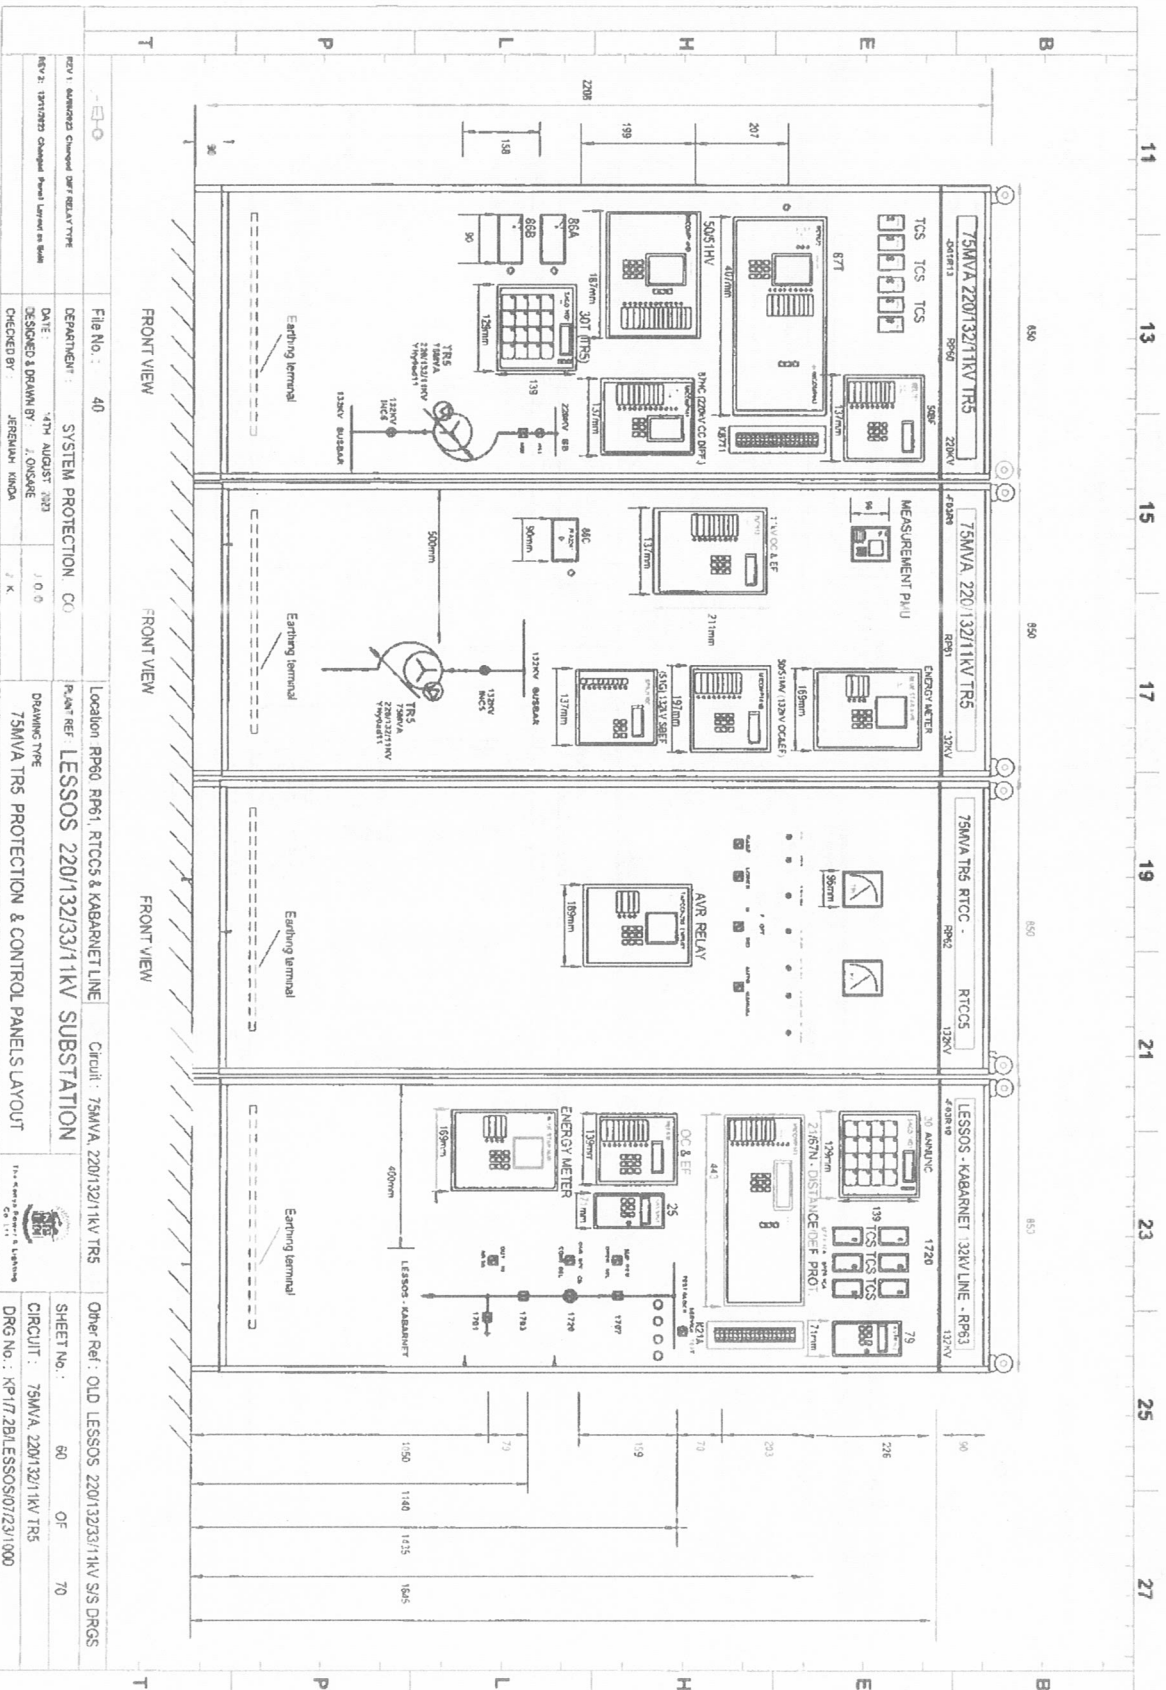


REV 1: ADVANCED CHANGE DEF RELAY TYPE
 REV 2: 132/132V Change Panel Layout in Bus

File No.: 40
 DEPARTMENT: SYSTEM PROTECTION CO
 DATE: 14TH AUGUST 2023
 DESIGNED & DRAWN BY: Z. OUSKAE
 CHECKED BY: JEREMAH NAKHA

Location: RPS6, RPS1, RTCC5 & KABARNET LINE
 PLAN REF: LESSOS 220/132/33/11KV SUBSTATION
 DRAWING TYPE: 75MVA TR5 PROTECTION & CONTROL PANELS LAYOUT



Other Ref.: OLD LESSOS 220/132/33/11KV SIS DRGS
 SHEET No.: 60 OF 70
 CIRCUIT: 75MVA 220/132/11KV TR5
 DRG No.: KP/17/2B/LESSOS/07/23/1000

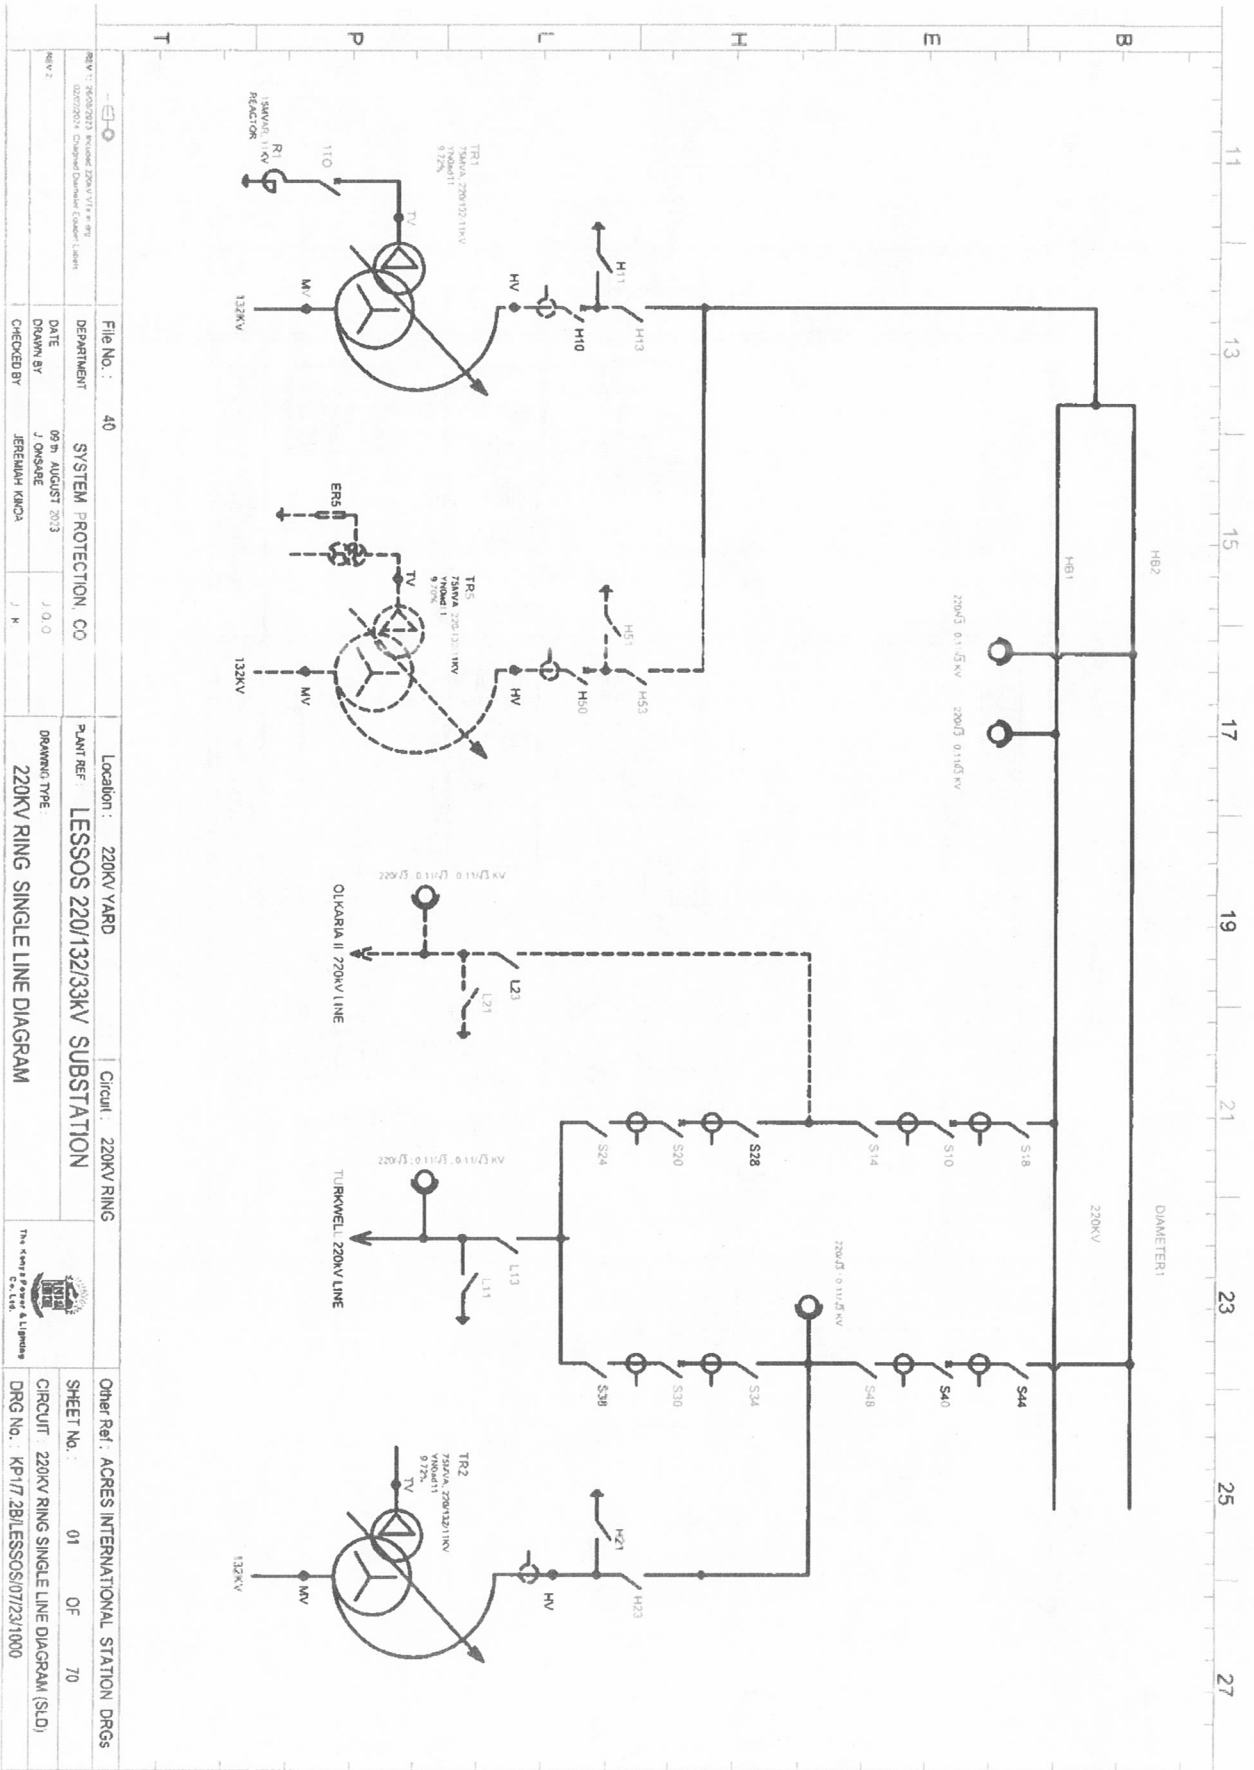

REV: 2003/02/01	Revised Drawn by: R. S. P.	FILE NO.: 40	Location: 220KV YARD	Circuit: 220KV/RING	Other Ref: ACRES INTERNATIONAL STATION DRGS
REV: 2003/02/01	Revised Drawn by: R. S. P.	DEPARTMENT: SYSTEM PROTECTION CO	Plant Ref: LESSOS 220/132/133KV SUBSTATION		SHEET No.: 01 OF 70
DATE: 09th AUGUST 2003	J. O. O.	DRAWN BY: J. O. O.	DRAMA TYPE: 220KV RING SINGLE LINE DIAGRAM		CIRCUIT: 220KV RING SINGLE LINE DIAGRAM (SLD)
CHECKED BY: JEREMAH KINCA	J. K.				DRG No.: KP/17 ZB/LESSOS/0723/1000

