


<p>DESCRIPTION</p> <p>KAMBURU 132KV S/S SINGLE LINE DIAGRAM</p>	<p>DRAWN BY</p> <p>JAPHETH NDUNDA</p>	<p>DATE DRAWN</p> <p>04/06/2014</p> <p>DATE REVISED</p> <p>25/07/2017</p>
--	--	---




LEGEND

	Circuit Breaker
	Disconnecter Switch
	Earth Switch
	Power Transformer
	Proposed 132kV Circuit Breaker
	Current Transformer
	Surge Diverter
	Voltage Transformer

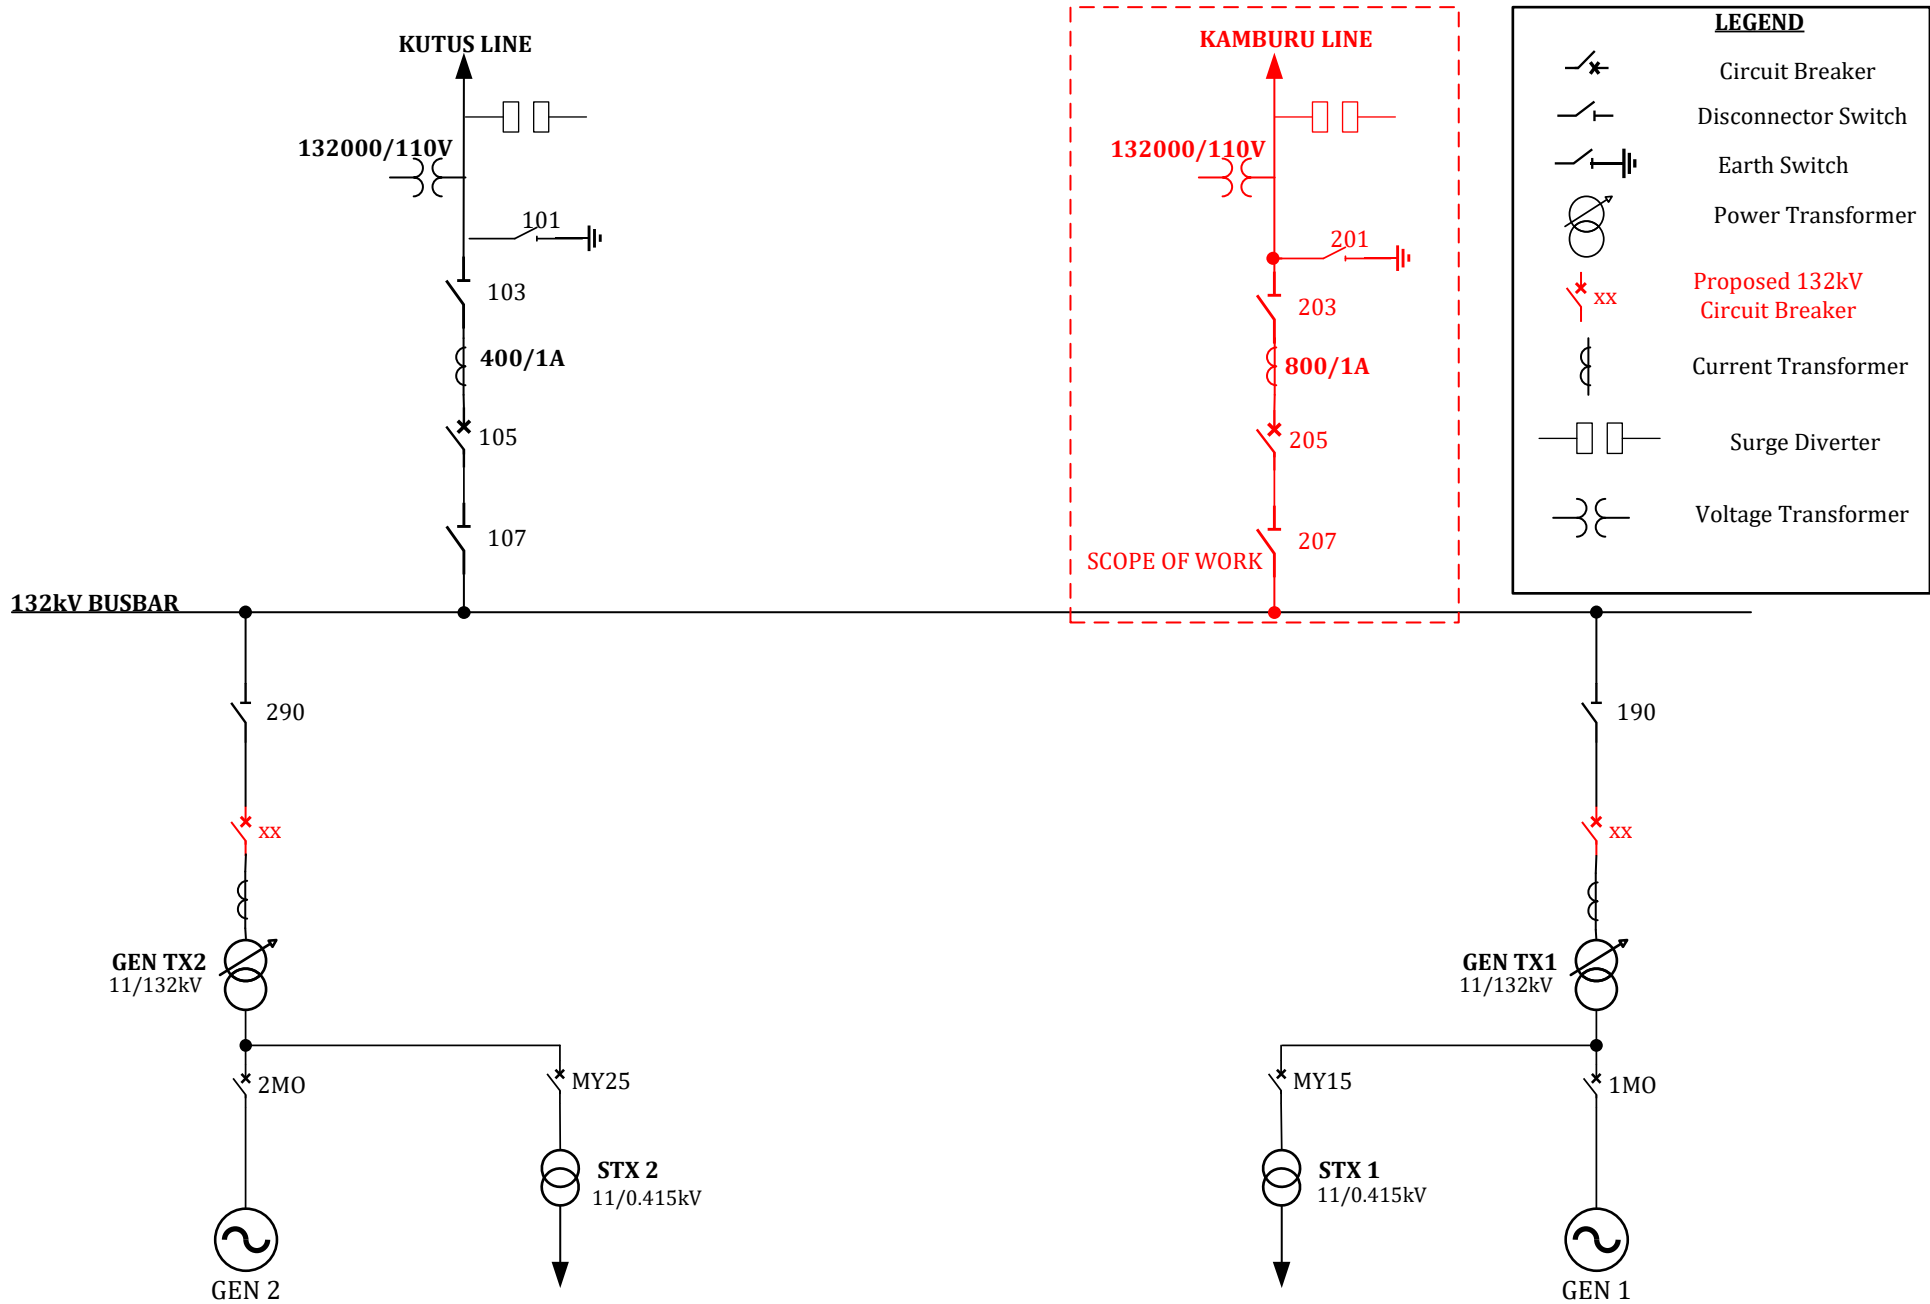

ORIGINAL DATE	12/10/2011	DESCRIPTION	DRAWN BY: Eng. ANTHONY GICHUKI
Rev 1	04/05/2021		
		MASINGA 11/132kV SUBSTATION	

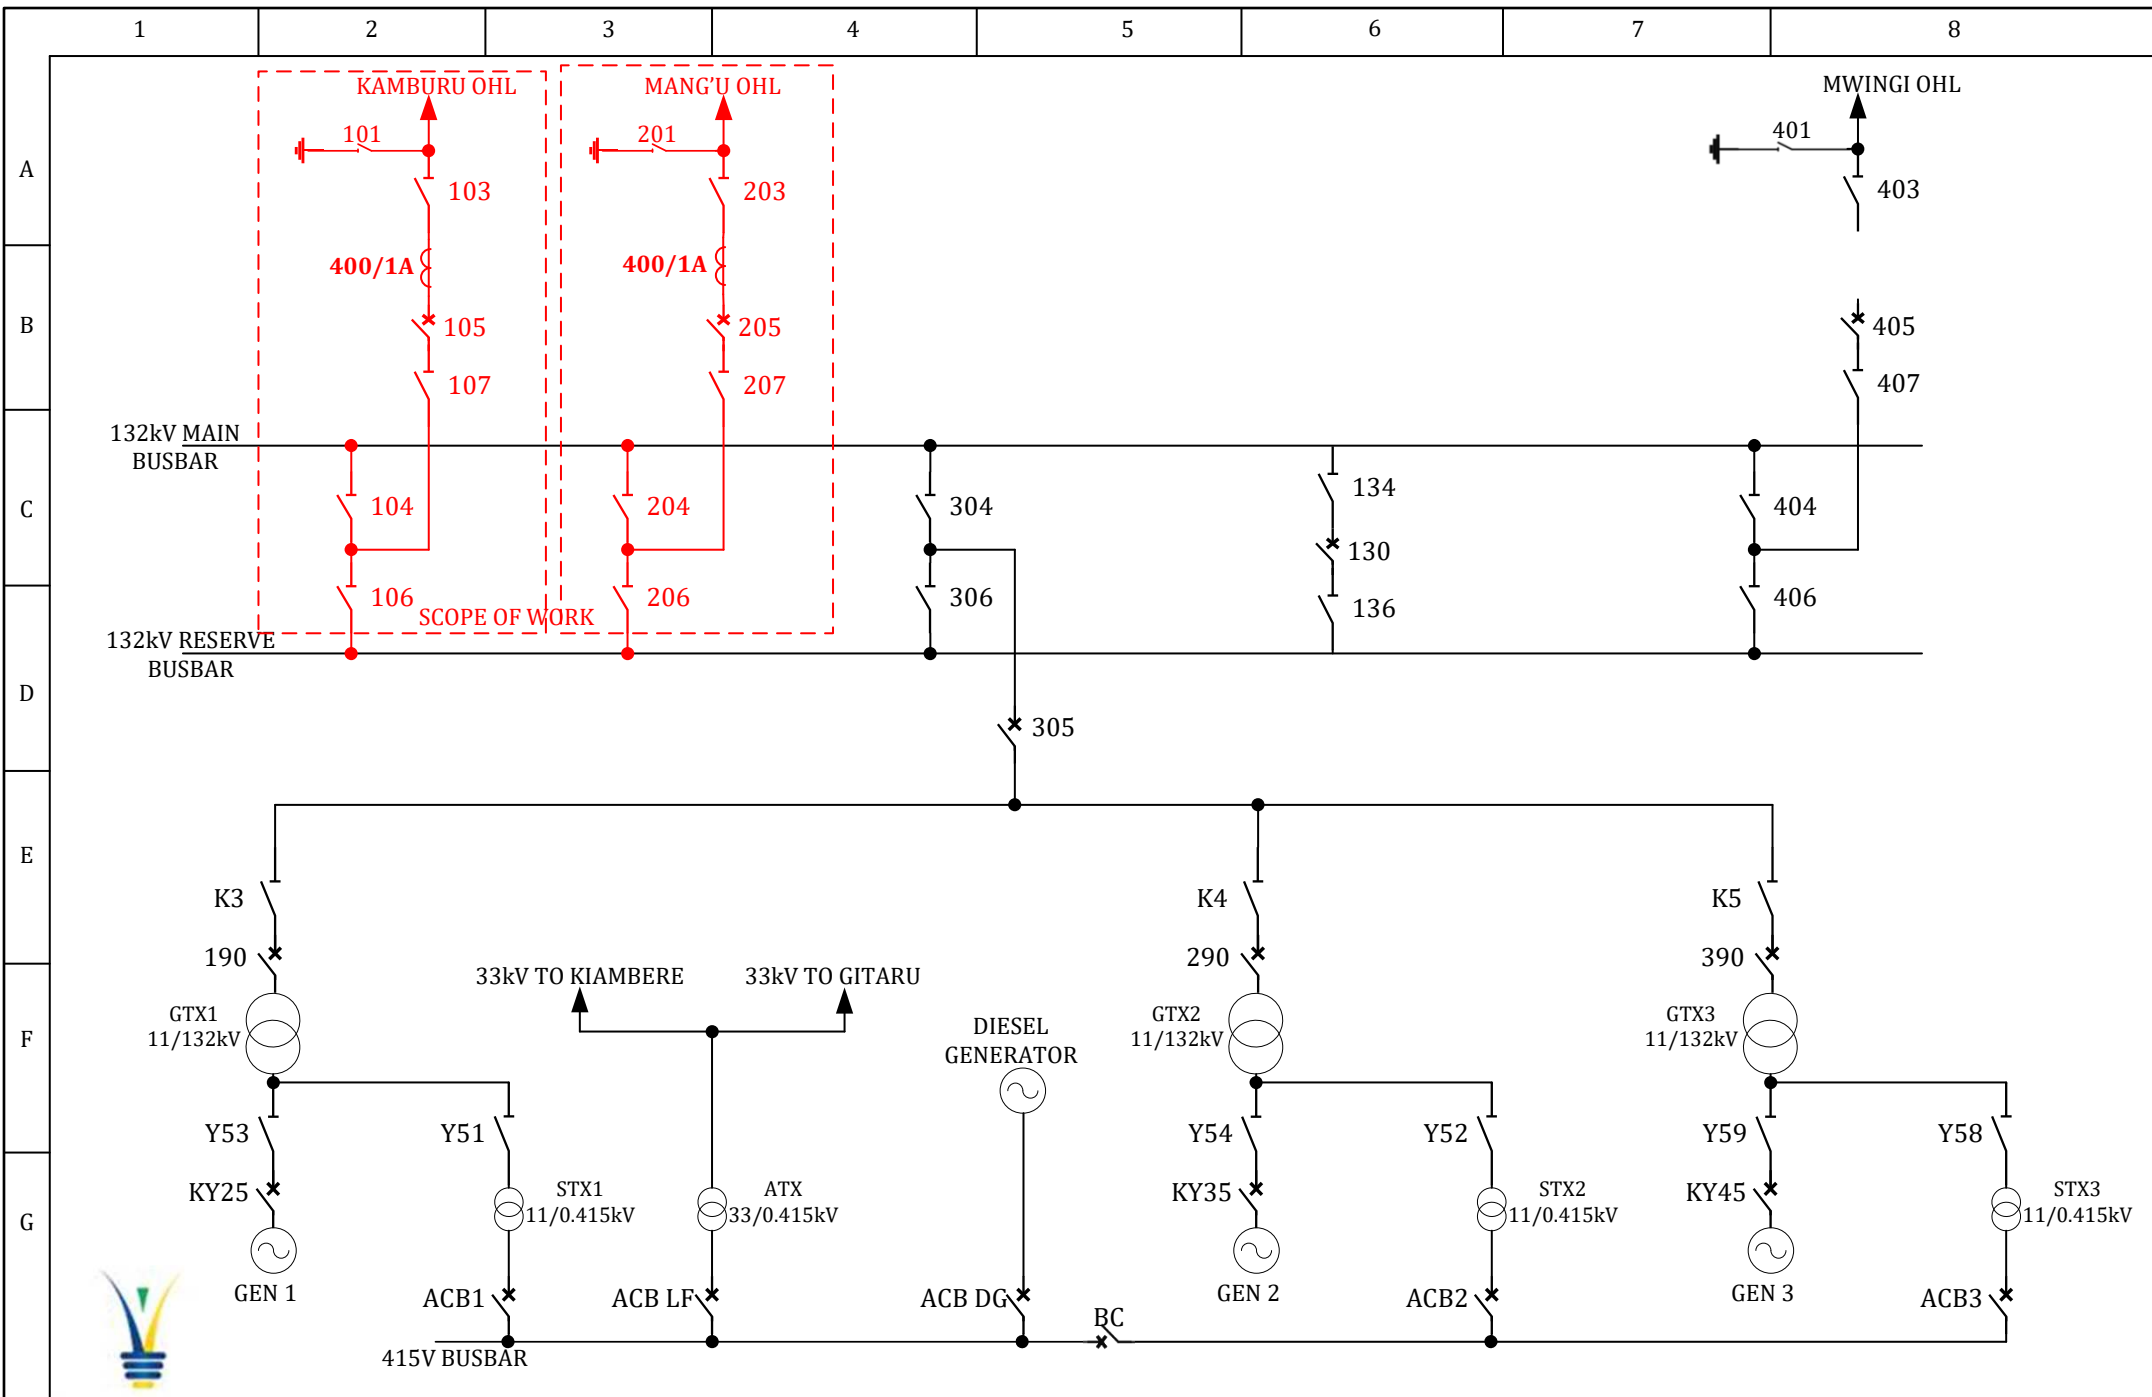

ORIGINAL DATE	22/09/2014	DESCRIPTION	SUBSTATION	DRAWN BY: Eng. ANTHONY GICHUKI.	NTS
REVISION 1	10/03/2022	SINGLE LINE DIAGRAM	KINDARUMA 132kV		